


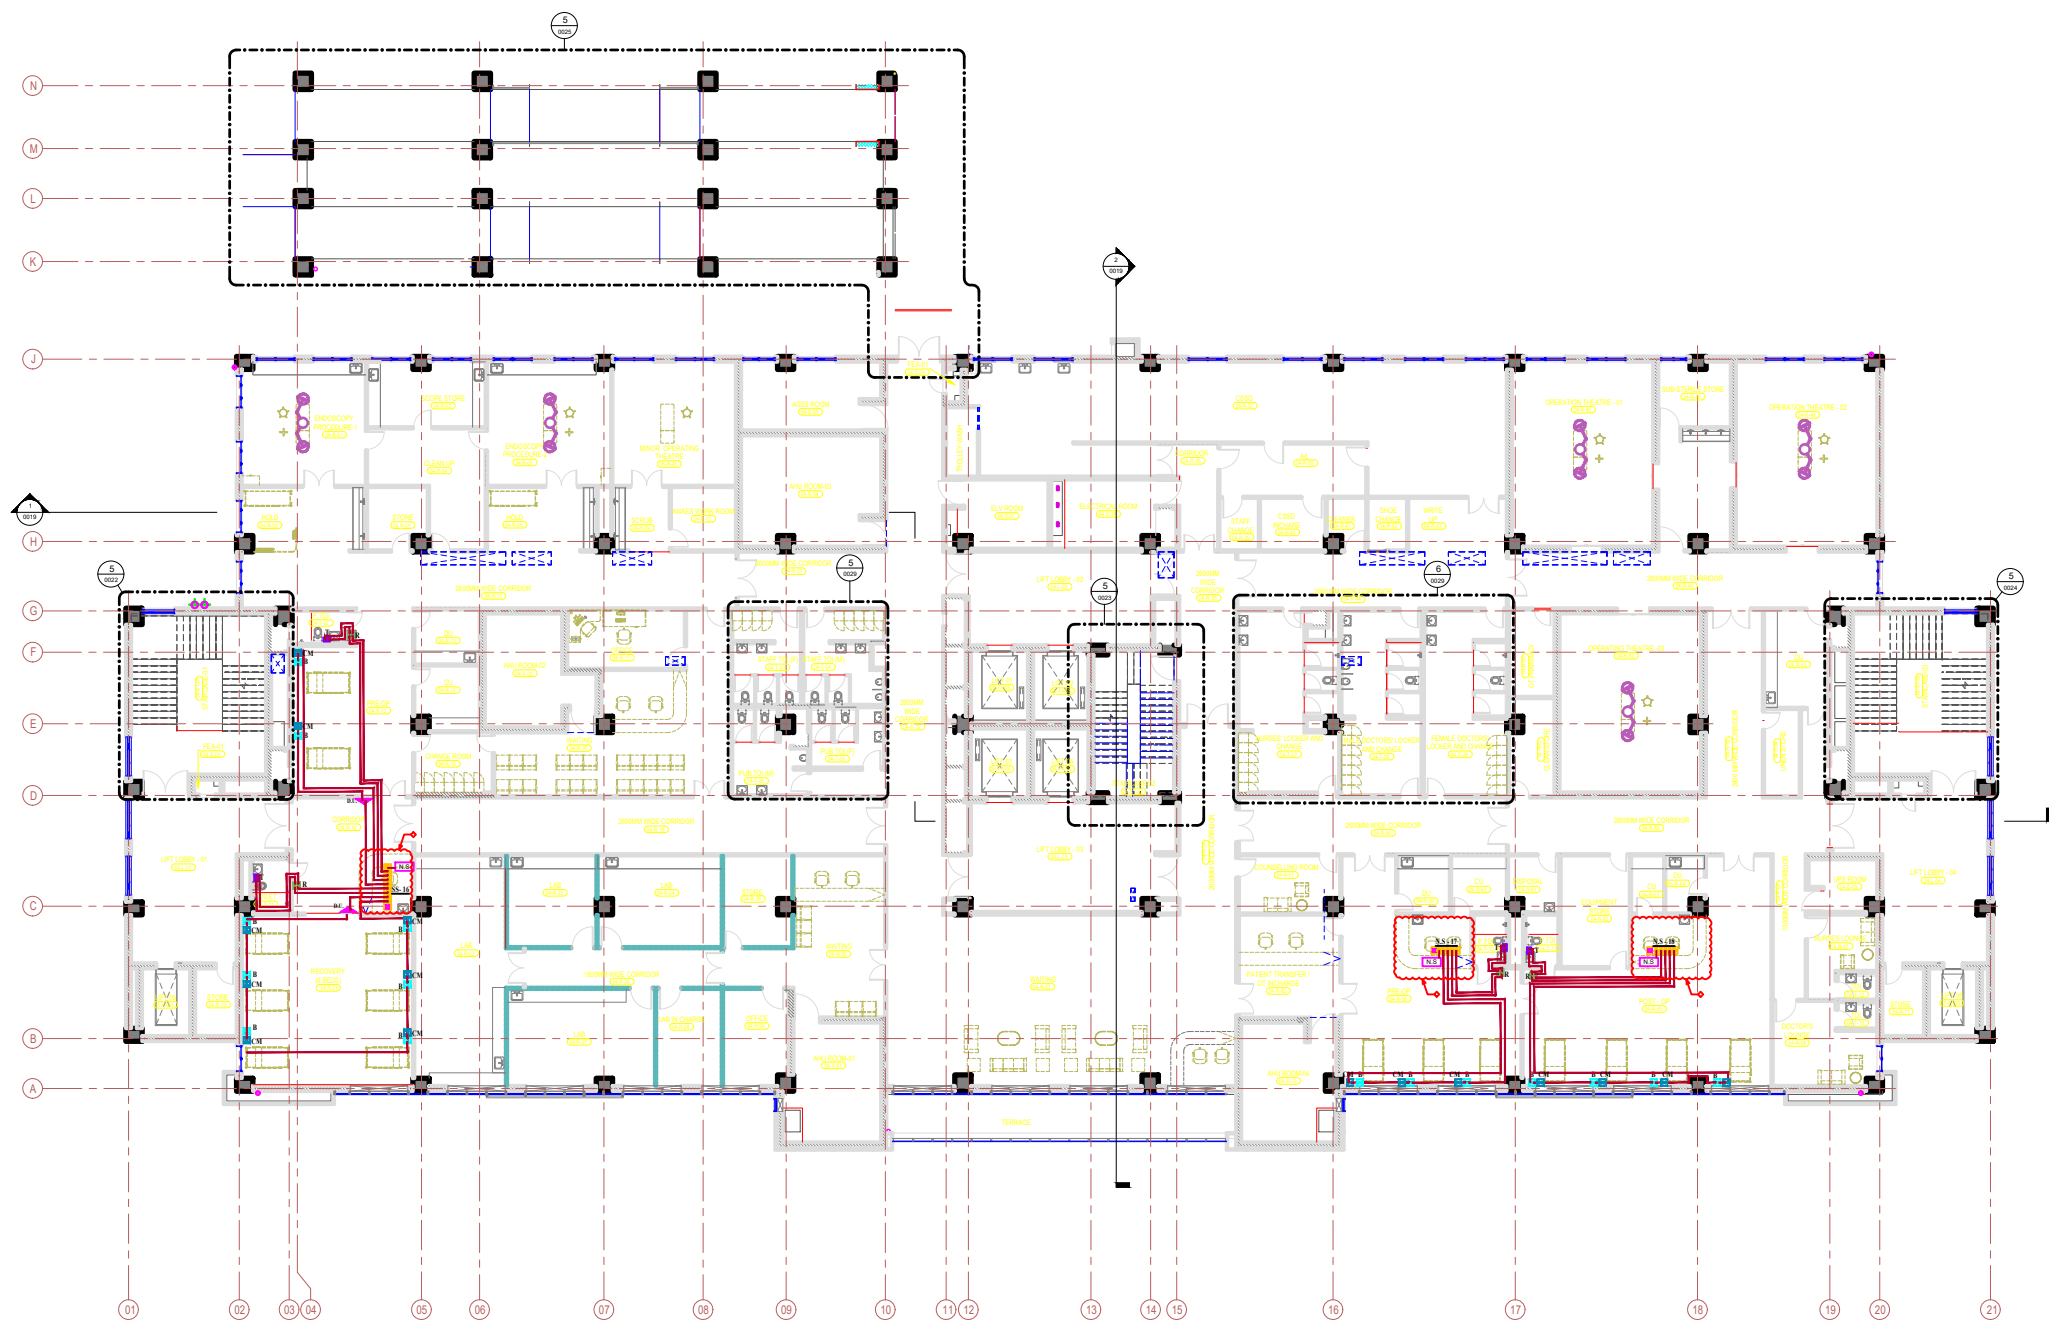

This drawing is the property of L&T Construction, BAF-EDRC and must not be passed on to any person or body not authorised by us to receive it nor be copied or otherwise made use either in full or in part by such person or body without our prior permission in writing.

NURSE CALL POINT LEGEND

SYMBOL	LEGEND	DESCRIPTION
	SS	SYSTEM SWITCH
	N.S	NURSE STATION
	DU	DOOR INDICATOR
	B	BED SIDE UNIT
	CM	CONNECTION MODULE
	R	EMERGENCY RESET UNIT
	T	TOILET PULL CORD
		CAT 6 CABLE

- ◆ Notes :
- 1.SHOP drawings to be submitted immediately with the provisions of power socket & LAN requirement
 2. This is only concept DWG,SHOP dwg to be submitted as per the BOQ

1	REVISED AS PER REVISION HISTORY-1 & RELEASED AS GOOD FOR CONSTRUCTION	DATE	20.03.2023	BY	A. S. S. S.	20.03.2023	BY	A. S. S. S.
2	RELEASED AS GOOD FOR CONSTRUCTION	DATE	20.03.2023	BY	A. S. S. S.	20.03.2023	BY	A. S. S. S.
REVNO	DESCRIPTION	DESIGNED	DRAWN	CHECKED	APPROVED			
CHECKED BY	DATE	CHECKED BY	DATE	CHECKED BY	DATE			
ARCHITECTURE		HVAC		GIS				
CIVIL & STRUCTURAL		FPS		GEOTECH				
ELECTRICAL		PIPING		WWT				
ELV SYSTEM		PVE						
CLIENT :								
ASSAM CANCER CARE FOUNDATION								
PROJECT : Proposed Cancer Centre At 18 Locations In Assam For Assam Cancer Care Foundation & M/s. Tolo Trusts			CONSULTANT : Engineering Design and Research Center (EDRC), L&T Construction - Buildings & Factories.					
DIPHU CANCER CENTRE			CONCEPT : Engineering Design and Research Center (EDRC), L&T Construction - Buildings & Factories.					
(A Government of Assam and Tolo Trusts Initiative)			ARCHITECT : L&T Construction - Buildings & Factories.					
SUPPLIER / CONTRACTOR : Larsen & Toubro Limited, Construction, Buildings & Factories								
JOB No : Q10035								
NAME			DATE	TITLE				
DESIGN	S.S.	S.S.	20.03.2023	NURSE CALL LAYOUT				
DRAWN	S.S.	S.S.	20.03.2023	FOURTH FLOOR PLAN				
CHECKED	A. S. S.	A. S. S.	20.03.2023					
APPROVED								
DRAWING No. TENDER/ACCF/NC/S/DIPHU-4			REV			0		
RELEASED FOR:			☒ PRELIMINARY ☐ TENDER ☐ INFORMATION ☐ APPROVAL ☐ CONSTRUCTION					